

NEW ADDITION
PREPARED FOR:
BRITT & NANCY BLACKALL

ABITA SPRINGS, LA.

DRAWING MODIFICATION DATE 10-28-19


- A1 COVER SHEET / SITE PLAN
- A2 FLOOR PLAN/SECOND FLOOR PLAN/FRONT ELEVATION
- A3 REAR ELEVATION/ LEFT SIDE ELEVATION
- A4 RIGHT SIDE ELEVATION
- A5 CONNECTOR DETAILS
- A6 DESIGN CRITERIA
- E1 ELECTRICAL PLAN
- F1 FOUNDATION PLAN

1 SCHED. OF DWGS.
N.T.S.

AREA'S


NEW ADDITION	634
2ND FLOOR	157
NEW PORCH	121
TOTAL	912

2 PROJECT DATA
N.T.S.

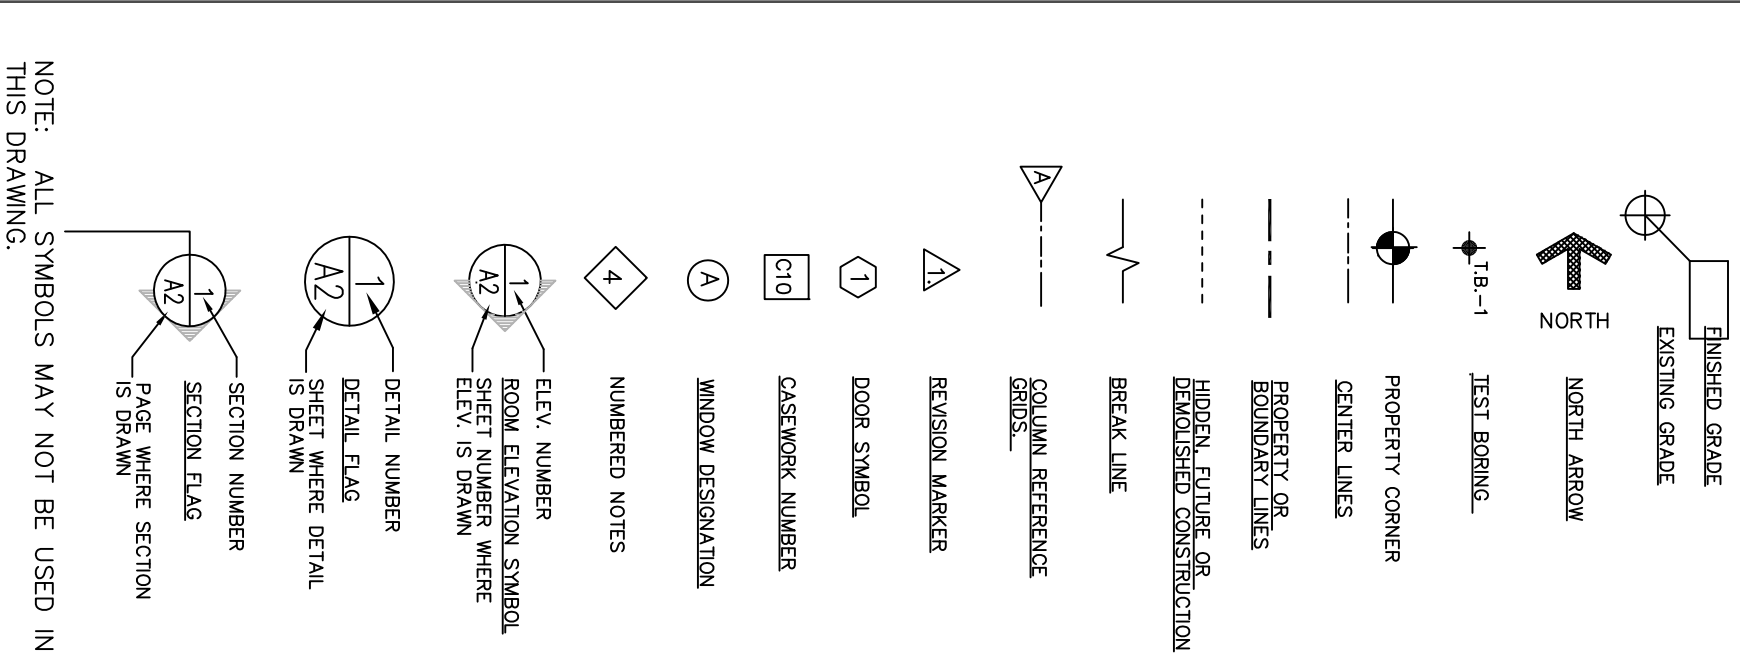


NOTE: ALL SYMBOLS MAY NOT BE USED IN THIS DRAWING.

3 GRAPHIC SYMBOLS
N.T.S.

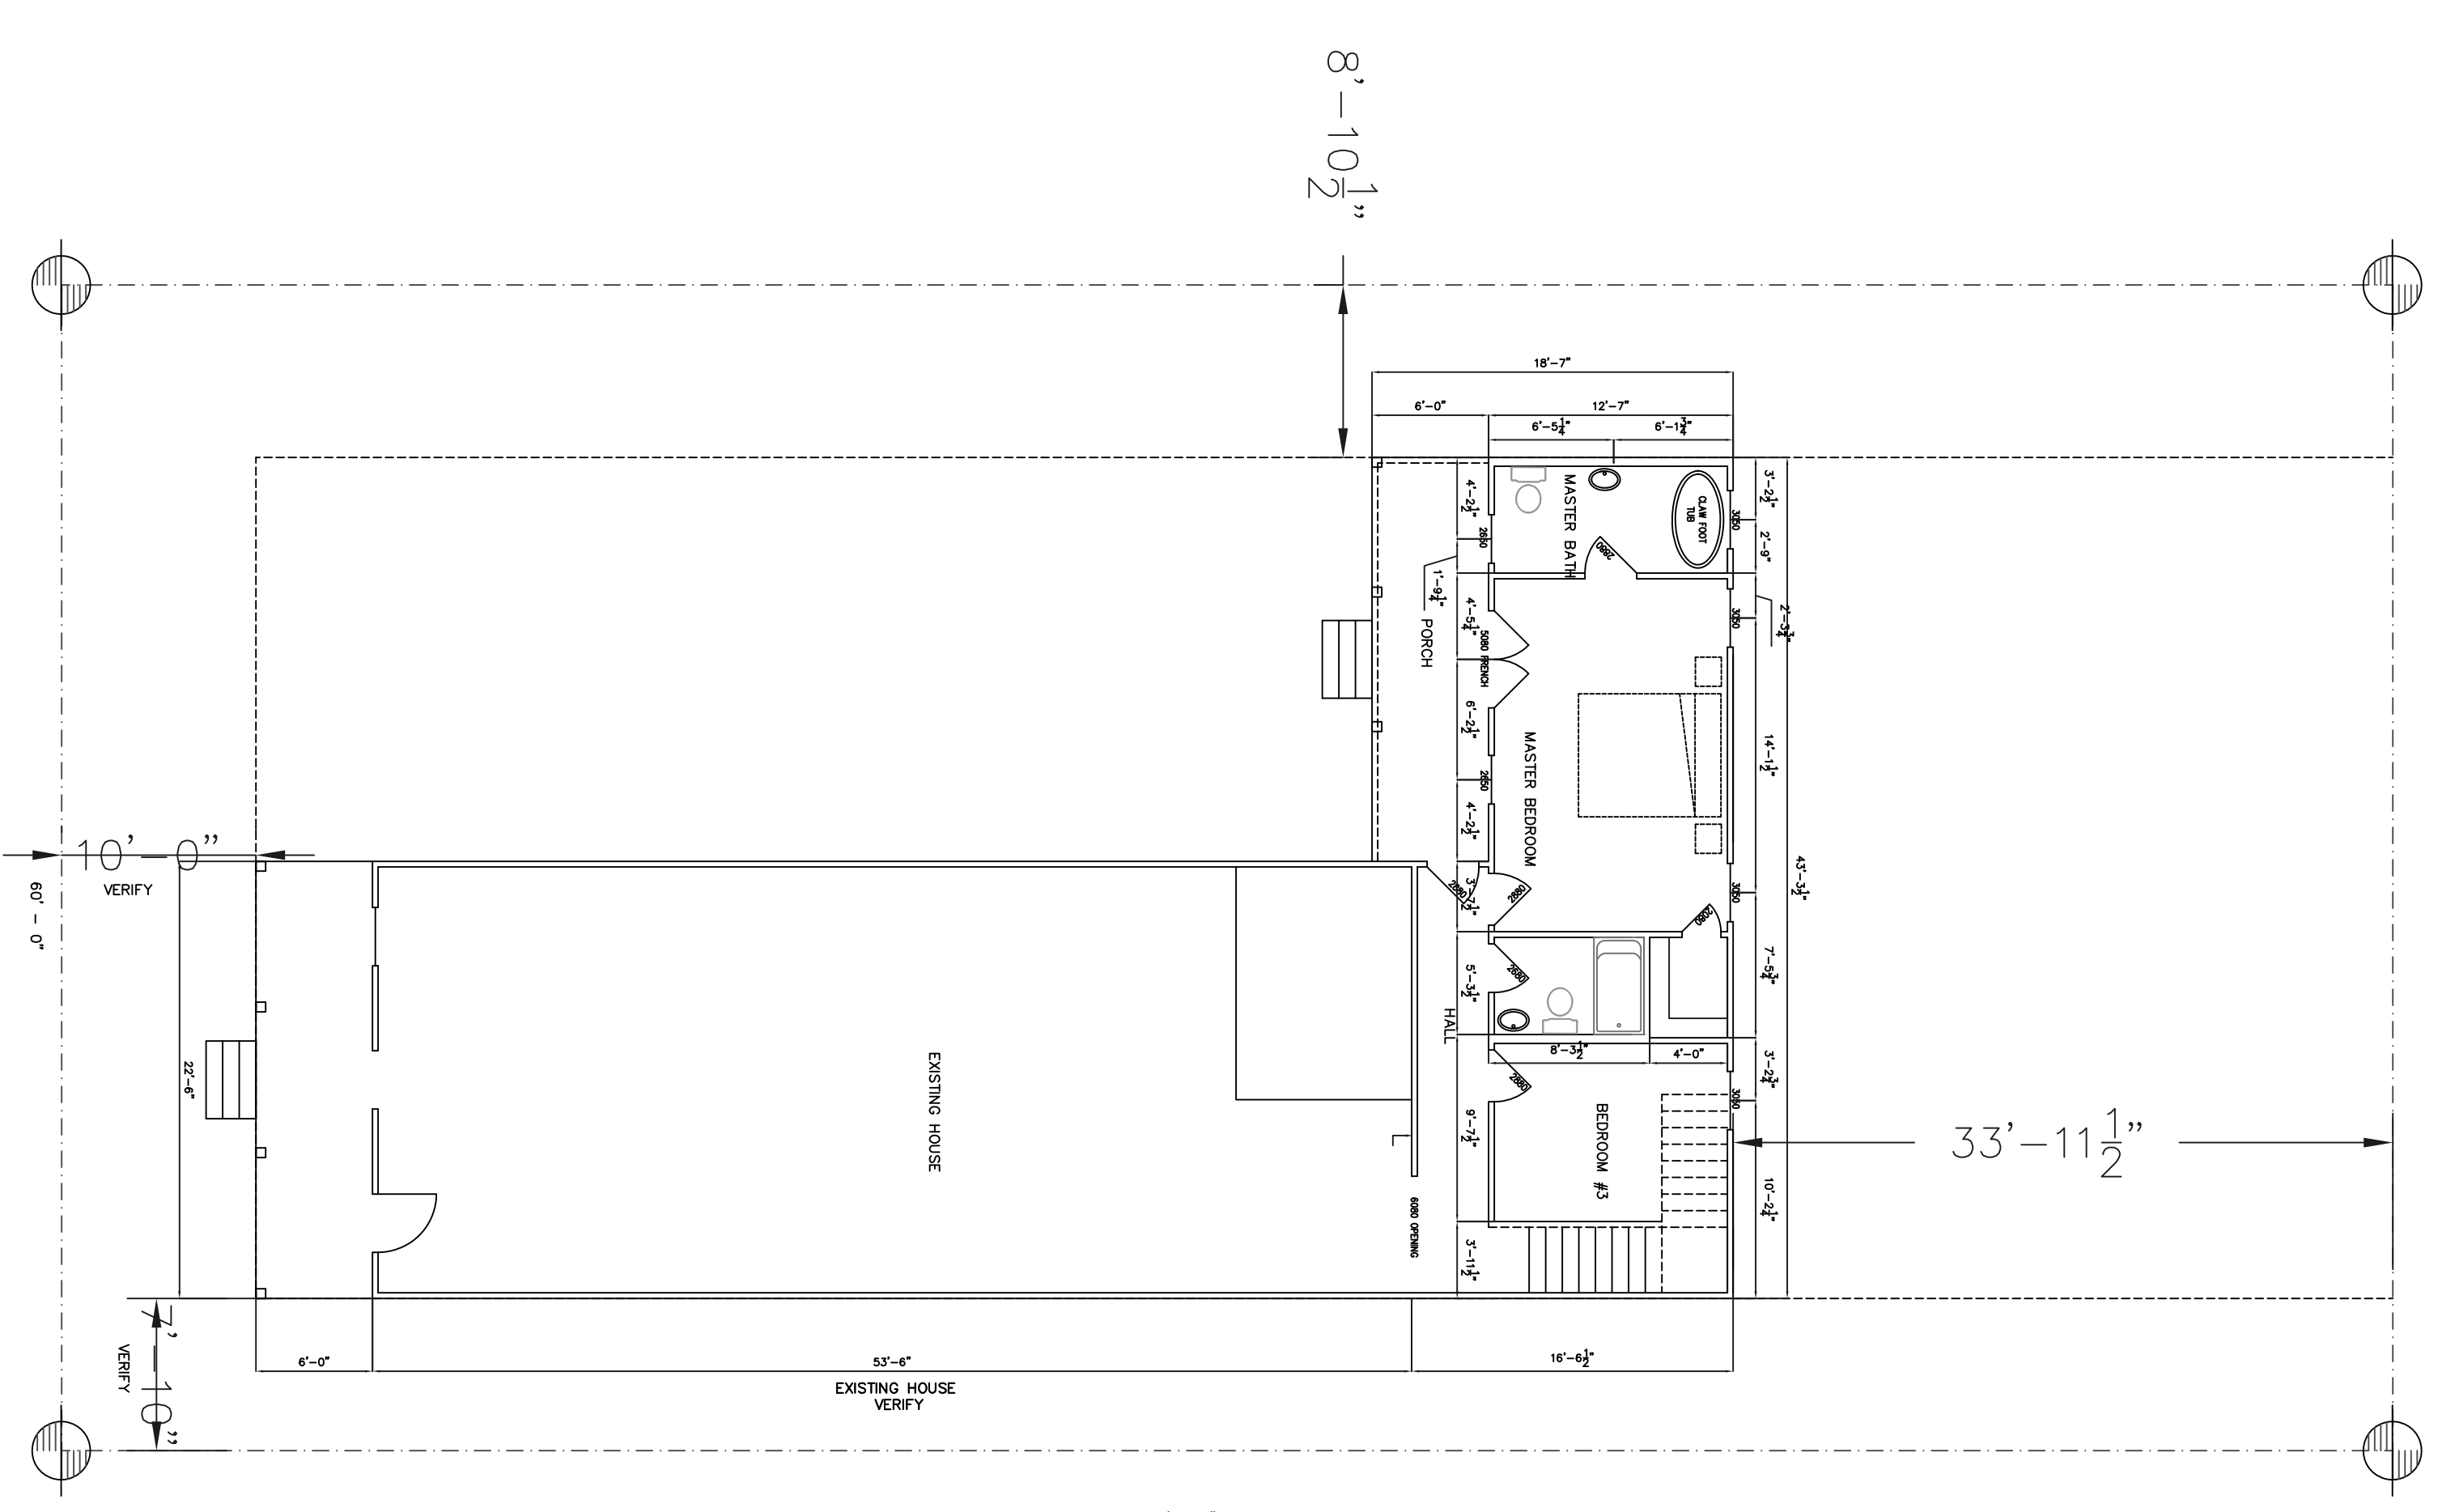

4 SITE PLAN
1/16" = 1'-0"

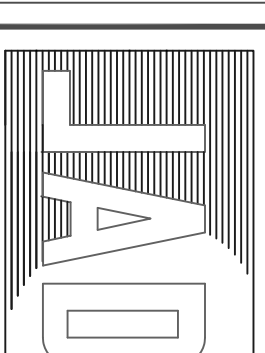

Joseph
&
Nancy
Blackall
designers and
planners

22247 7TH STREET
ABITA SPRINGS, LA
70420
(985) 893-2074


DRAWING
RELEASED
FOR:

- PRELIMINARY - NOT FOR CONSTRUCTION
- PENDING - NOT FOR CONSTRUCTION
- FOR CONSTRUCTION


DRAWING RELEASE DATES	
NO.	DATE PURPOSE
1.	10/28/19
2.	
3.	
4.	

NEW ADDITION
PREPARED FOR:
MR. AND MRS. BLACKALL


SHEET NO.
OF: A1

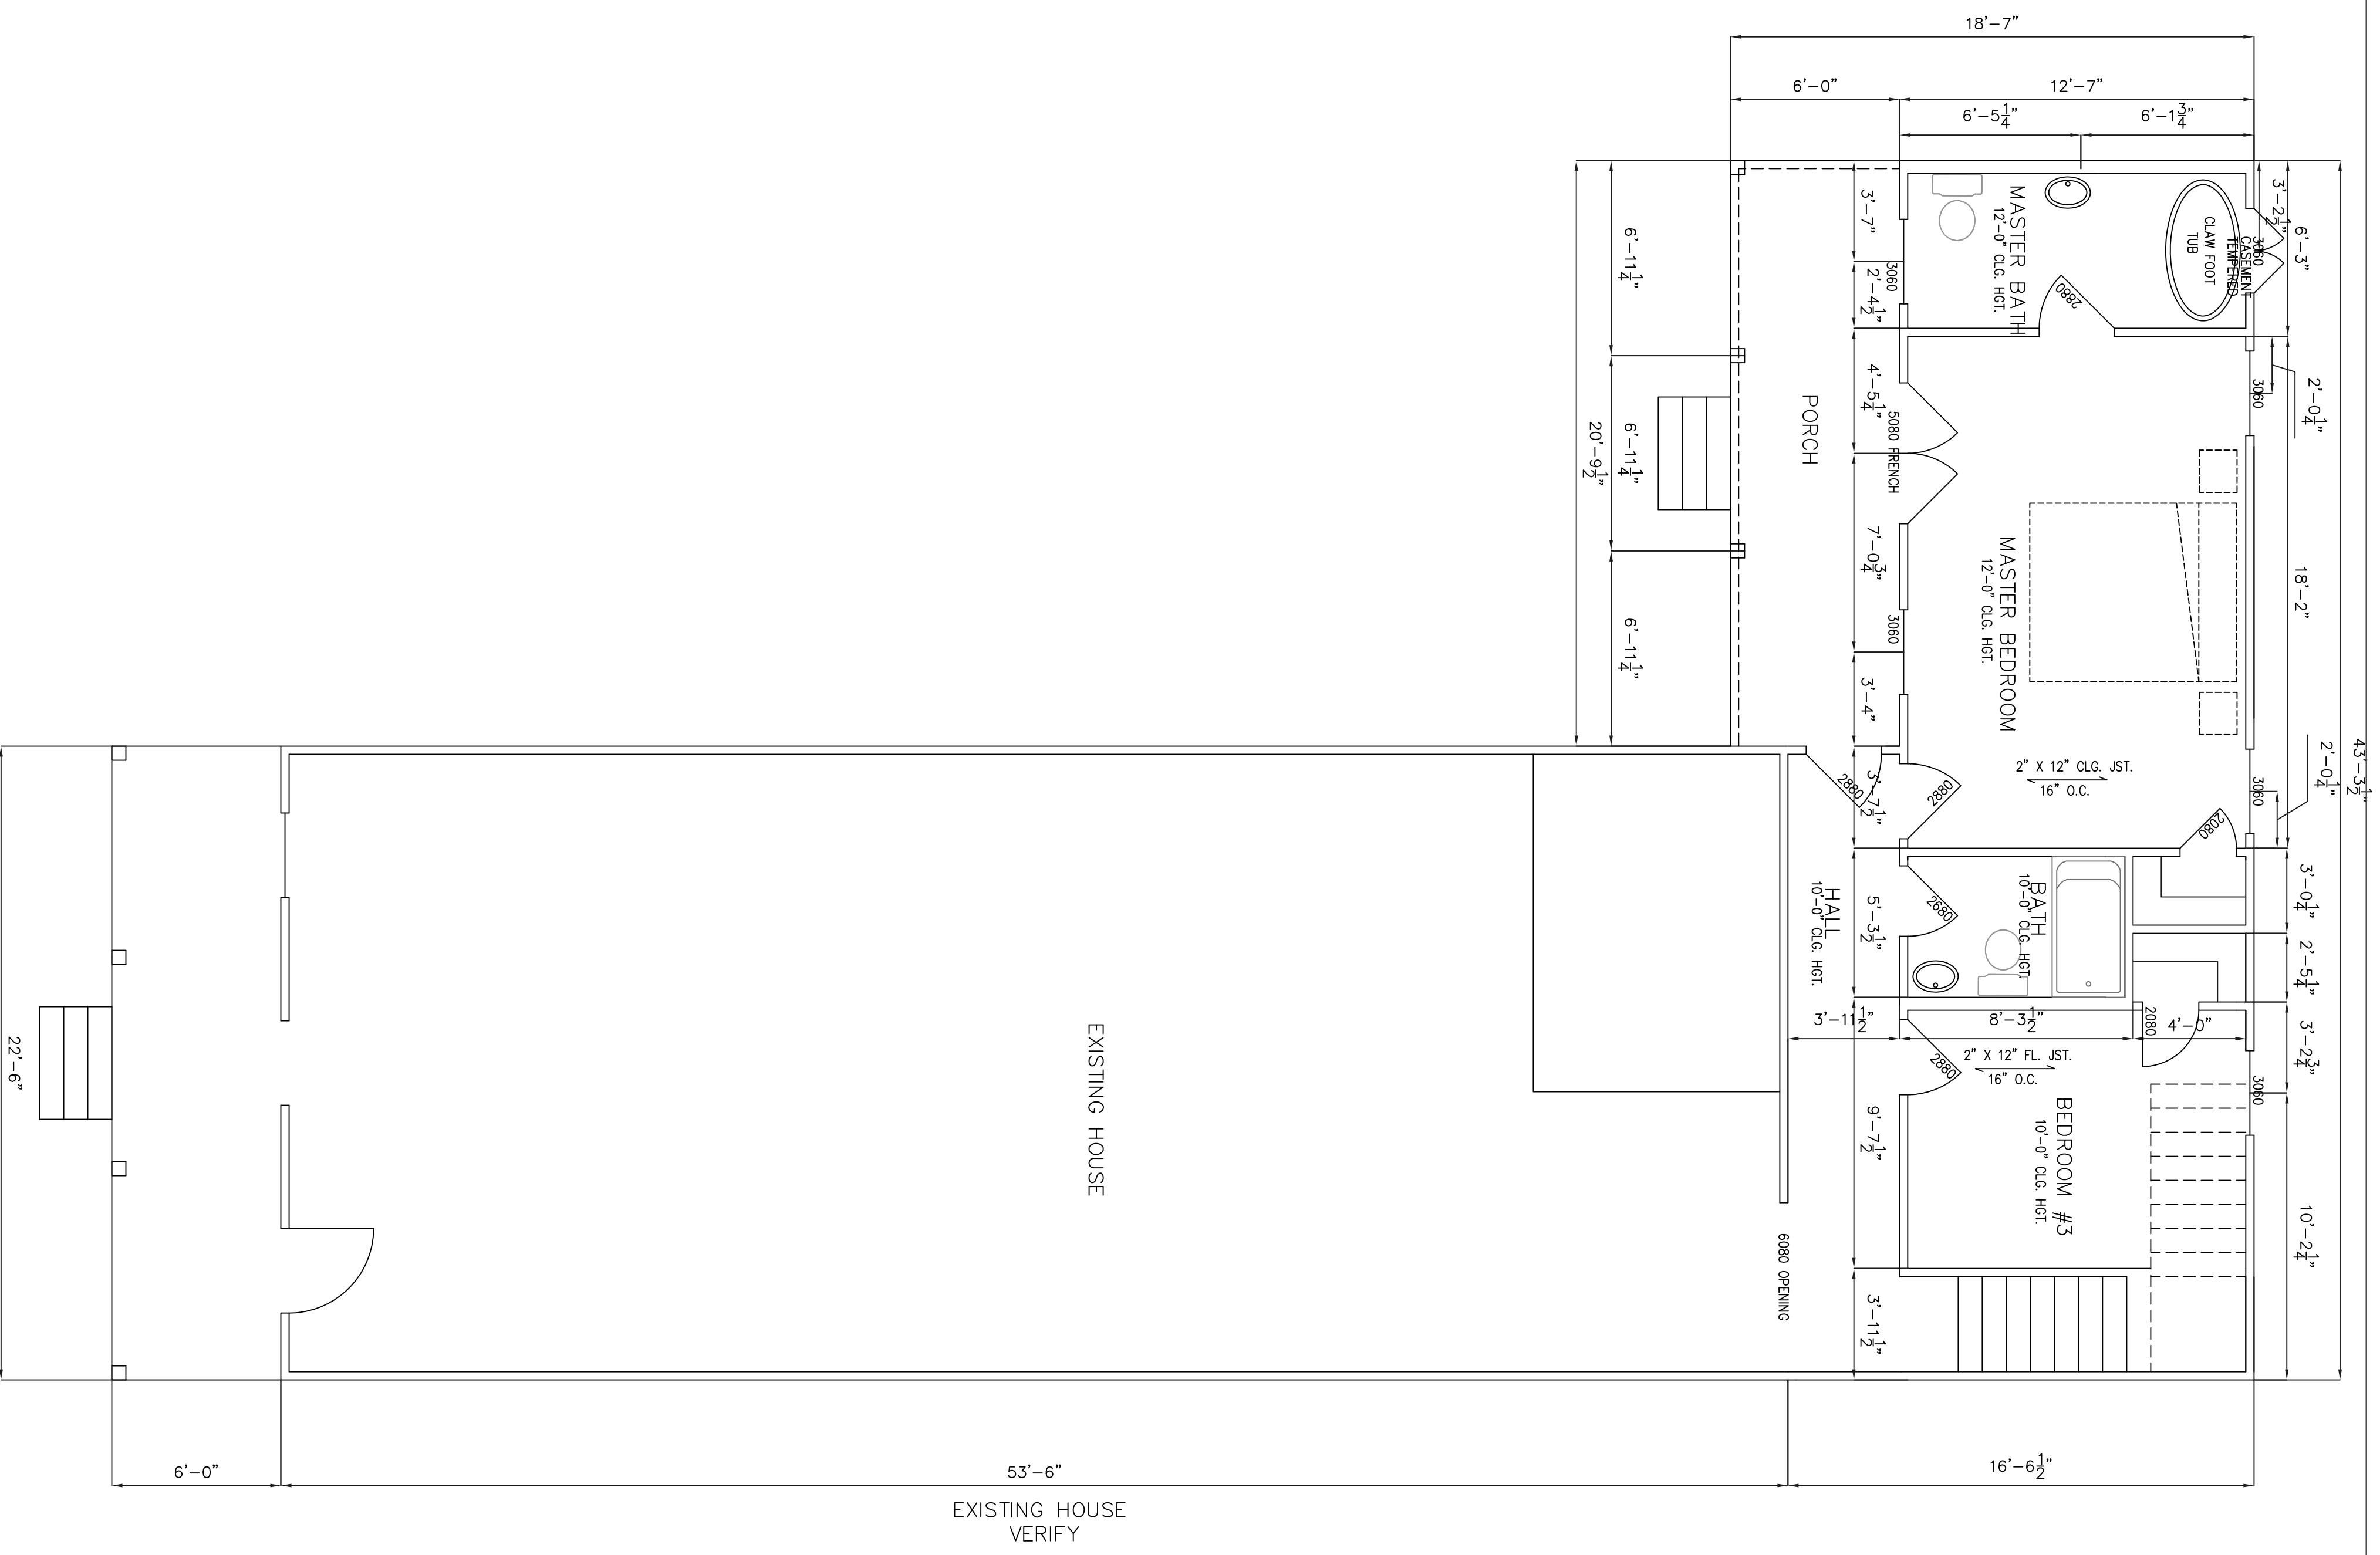


1. FLOOR PLAN
1/4" = 1'-0"

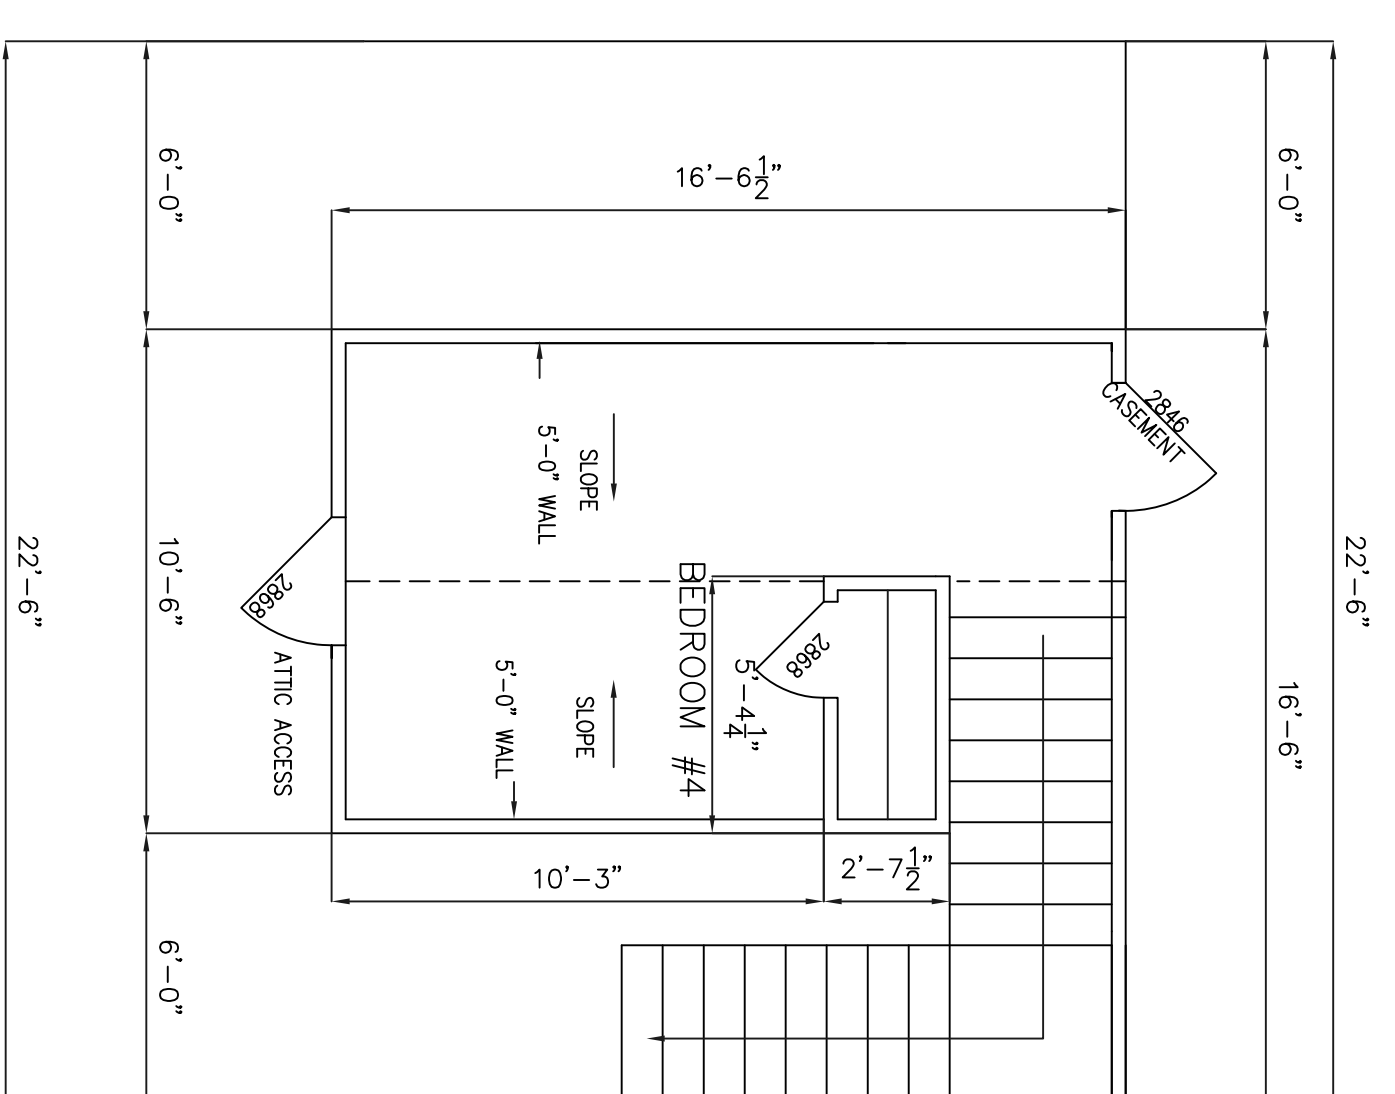

2. SECOND FLOOR BEDROOM
1/4" = 1'-0"

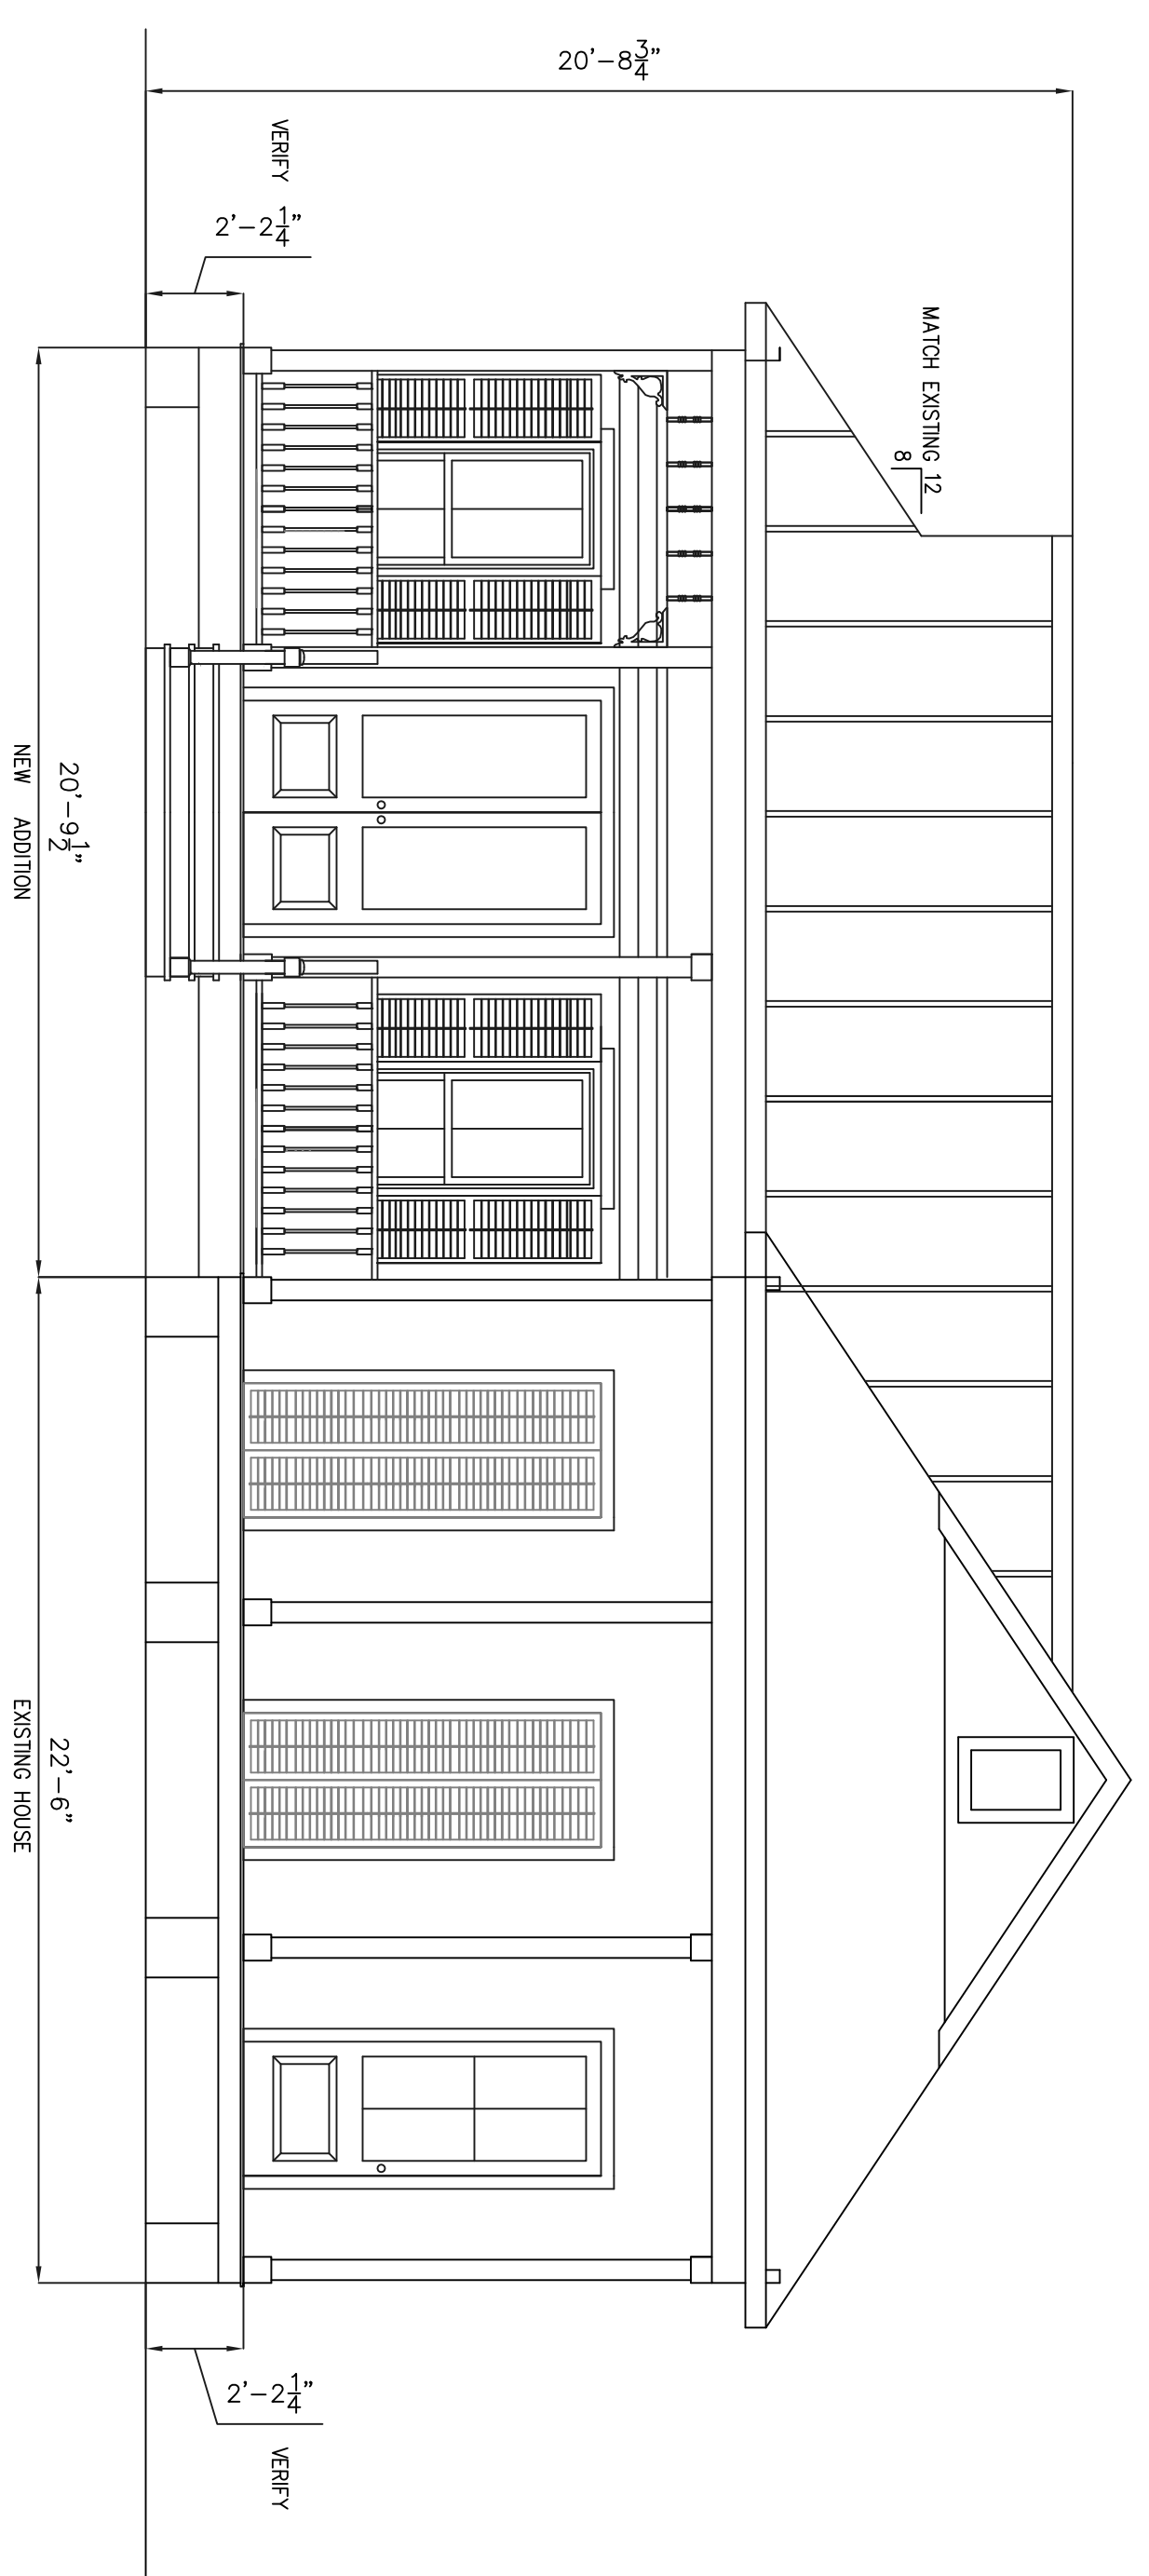

3. NEW PROPOSED FRONT ELEVATION
1/2" = 1'-0"

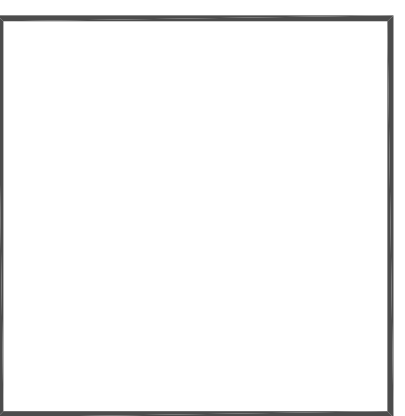

joseph
and
associates
designers and
planners

22247 7TH, STREET
ABITA SPRINGS, LA
70420
(985) 893-2074


DRAWING
RELEASED
FOR:

- PRELIMINARY - NOT FOR CONSTRUCTION
- PRICING: NOT FOR CONSTRUCTION
- FOR CONSTRUCTION


DRAWING RELEASE DATES		
NO.	DATE	PURPOSE
1	10/28/18	
2	10/29/18	
3	10/29/18	
4		

NEW ADDITION
PREPARED FOR:
BRITT & NANCY BLACKALL


SHEET NO.
OF: A2

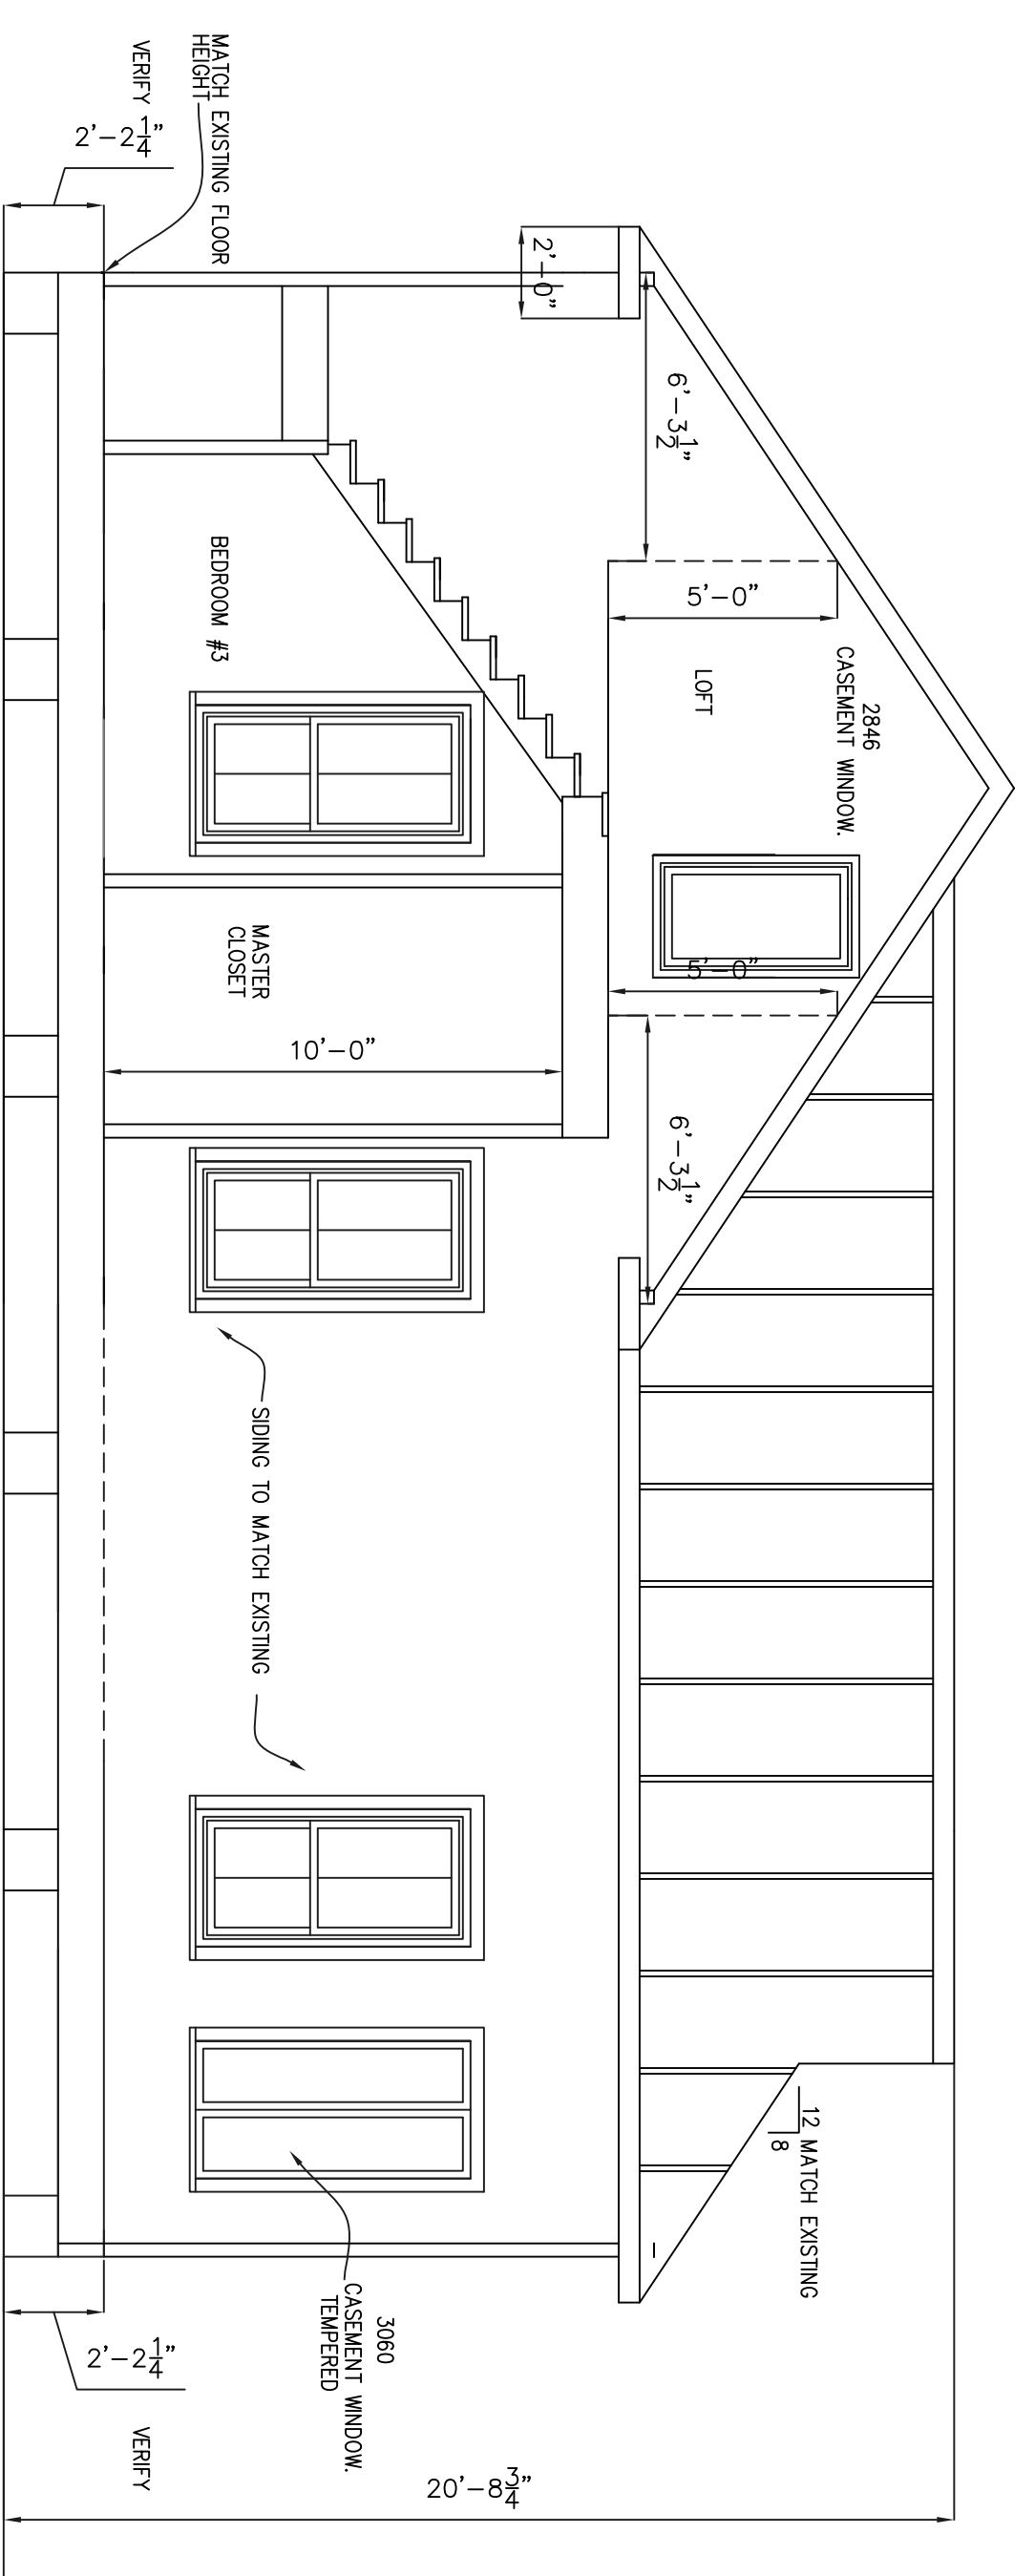

1. NEW PROPOSED REAR ELEVATION

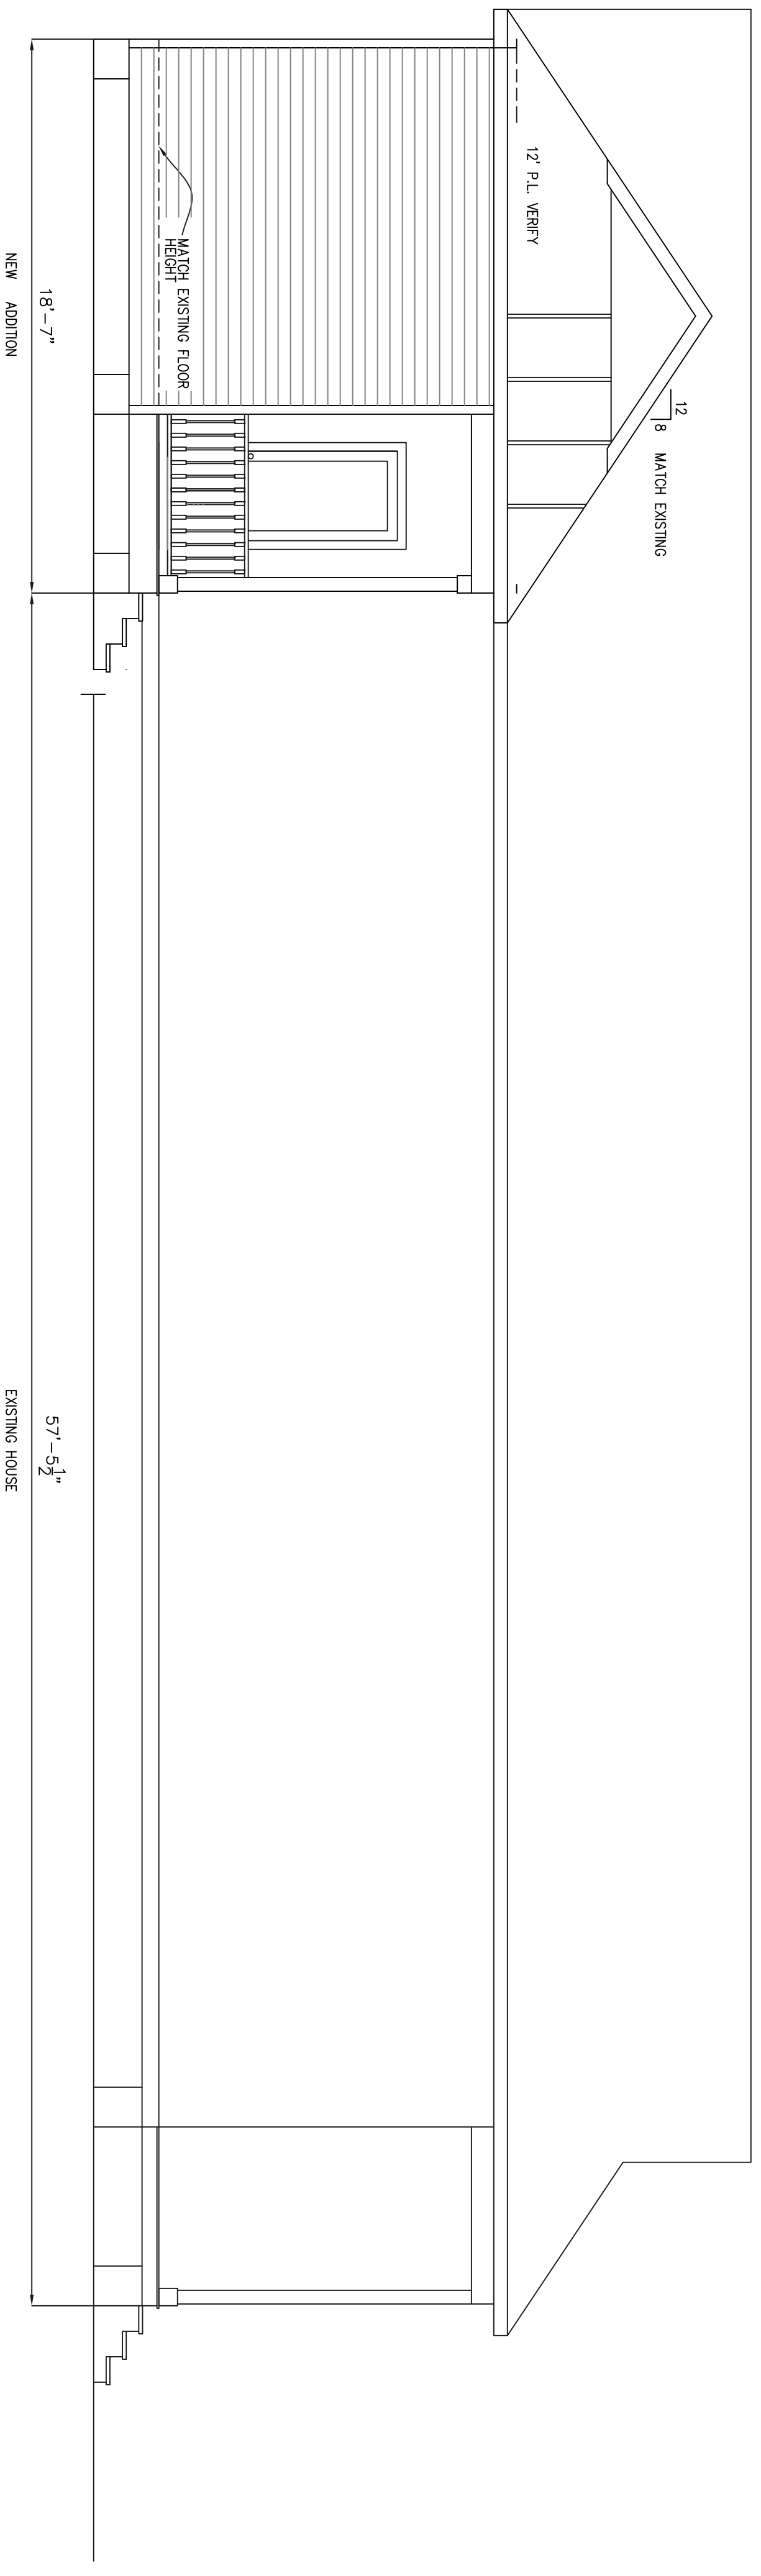

2. NEW PROPOSED LEFT SIDE ELEVATION

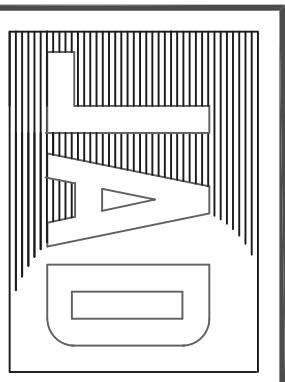

Joseph
A
day
and
associates
designers and
planners

22247 7TH, STREET
AZITA SPRINGS, LA
70420
(985) 993-2074


DRAWING
RELEASED
FOR:

- PRELIMINARY - NOT FOR CONSTRUCTION
- PRICING - NOT FOR CONSTRUCTION
- FOR CONSTRUCTION


DRAWING RELEASE DATES	
NO.	DATE
1.	10/19/18
2.	10/21/18
3.	10/29/18
4.	

NEW ADDITION
PREPARED FOR:
BRITT & NANCY BLACKALL

SHEET NO.
OF: A3

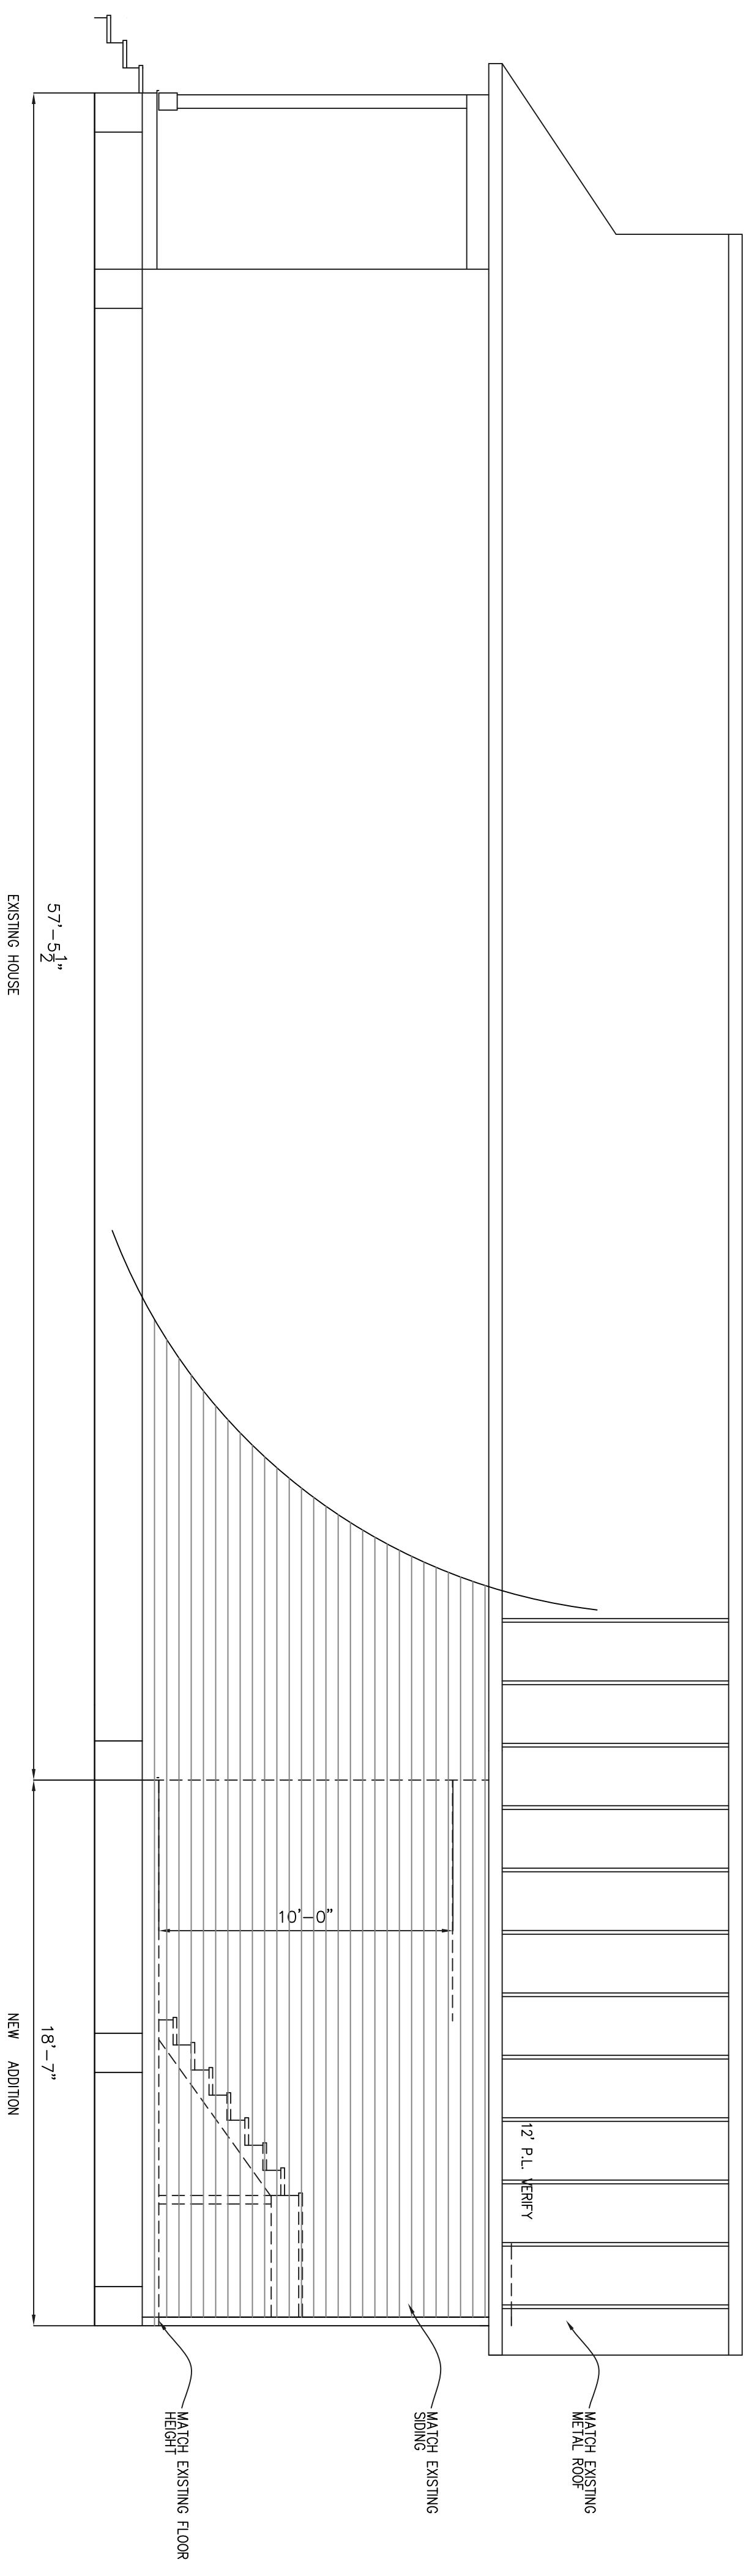

1. NEW PROPOSED RIGHT SIDE ELEVATION

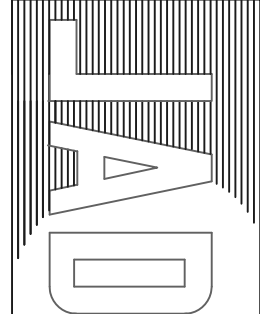

 joseph d. day and associates designers and planners

22247 7TH STREET
 ABITA SPRINGS, LA 70420
 (985) 893-2074

DRAWING RELEASED FOR:
 PRELIMINARY - NOT FOR CONSTRUCTION
 PRICING - NOT FOR CONSTRUCTION
 FOR CONSTRUCTION

DRAWING RELEASE DATES	
NO.	DATE
1.	10/18/18
2.	10/21/18
3.	10/28/18
4.	

NEW ADDITION PREPARED FOR:
 BRITT & NANCY BLACKALL